



CLEAN POWER
MANAGEMENT

24941 DANA POINT HARBOR DR
SUITE C220
DANA POINT, CA 92629
469-735-2234

This document is © by the engineer and is considered an instrument of service and is only for use with respect to the project as indicated below. All rights reserved. This document may not be reproduced without the prior written consent of the engineer.

SEAL:

PROJECT:

PROJ-1183

MA SOUTHBRIDGE A
0 CLEMENCE HILL ROAD
SOUTHBRIDGE, MA
42.092797, -72.035324

APN: 017-001-00001

OWNER:

PROJECT SOUTHBRIDGE MA
1, LLC (CONED)

24941 DANA POINT HARBOR
DR., C220, DANA POINT, CA
92629

Revisions:

1	05/02/22	equipment changes
2	08/25/22	equipment changes
3	08/31/22	Utility Restudy
4	10/03/22	Utility Restudy, add sh. E3.01
5	10/17/22	Utility Restudy, relay settings
6	05/30/23	Re-Design using Solectria equip.
7	06/12/23	Grounding XFMR update
8	08/03/23	Updated Pole Design

Drawn By:

DL

Checked By:

DS

Date:

06/09/2023



Job No.:

Sheet Title:

ELECTRICAL
SITE PLAN

Sheet No.:

E-1.0

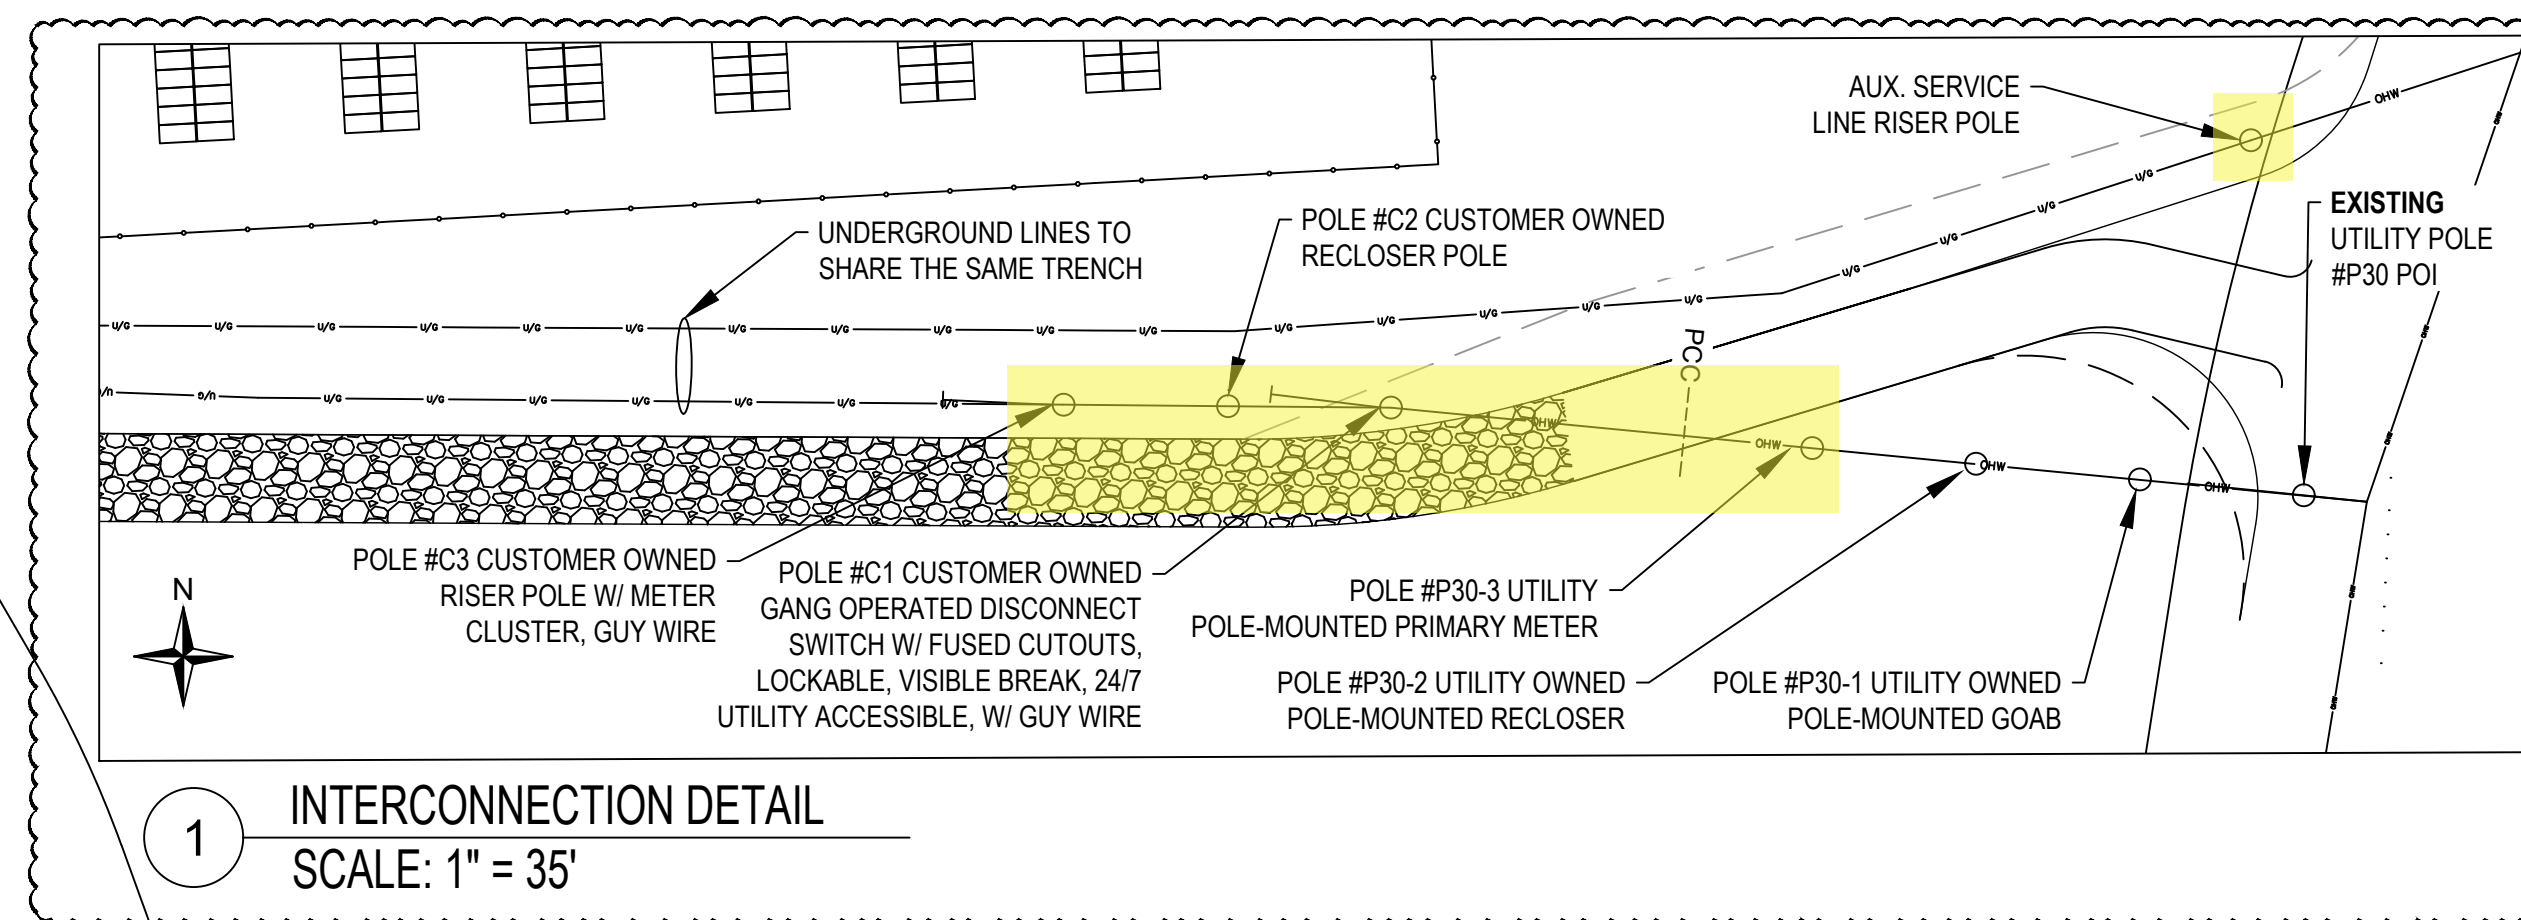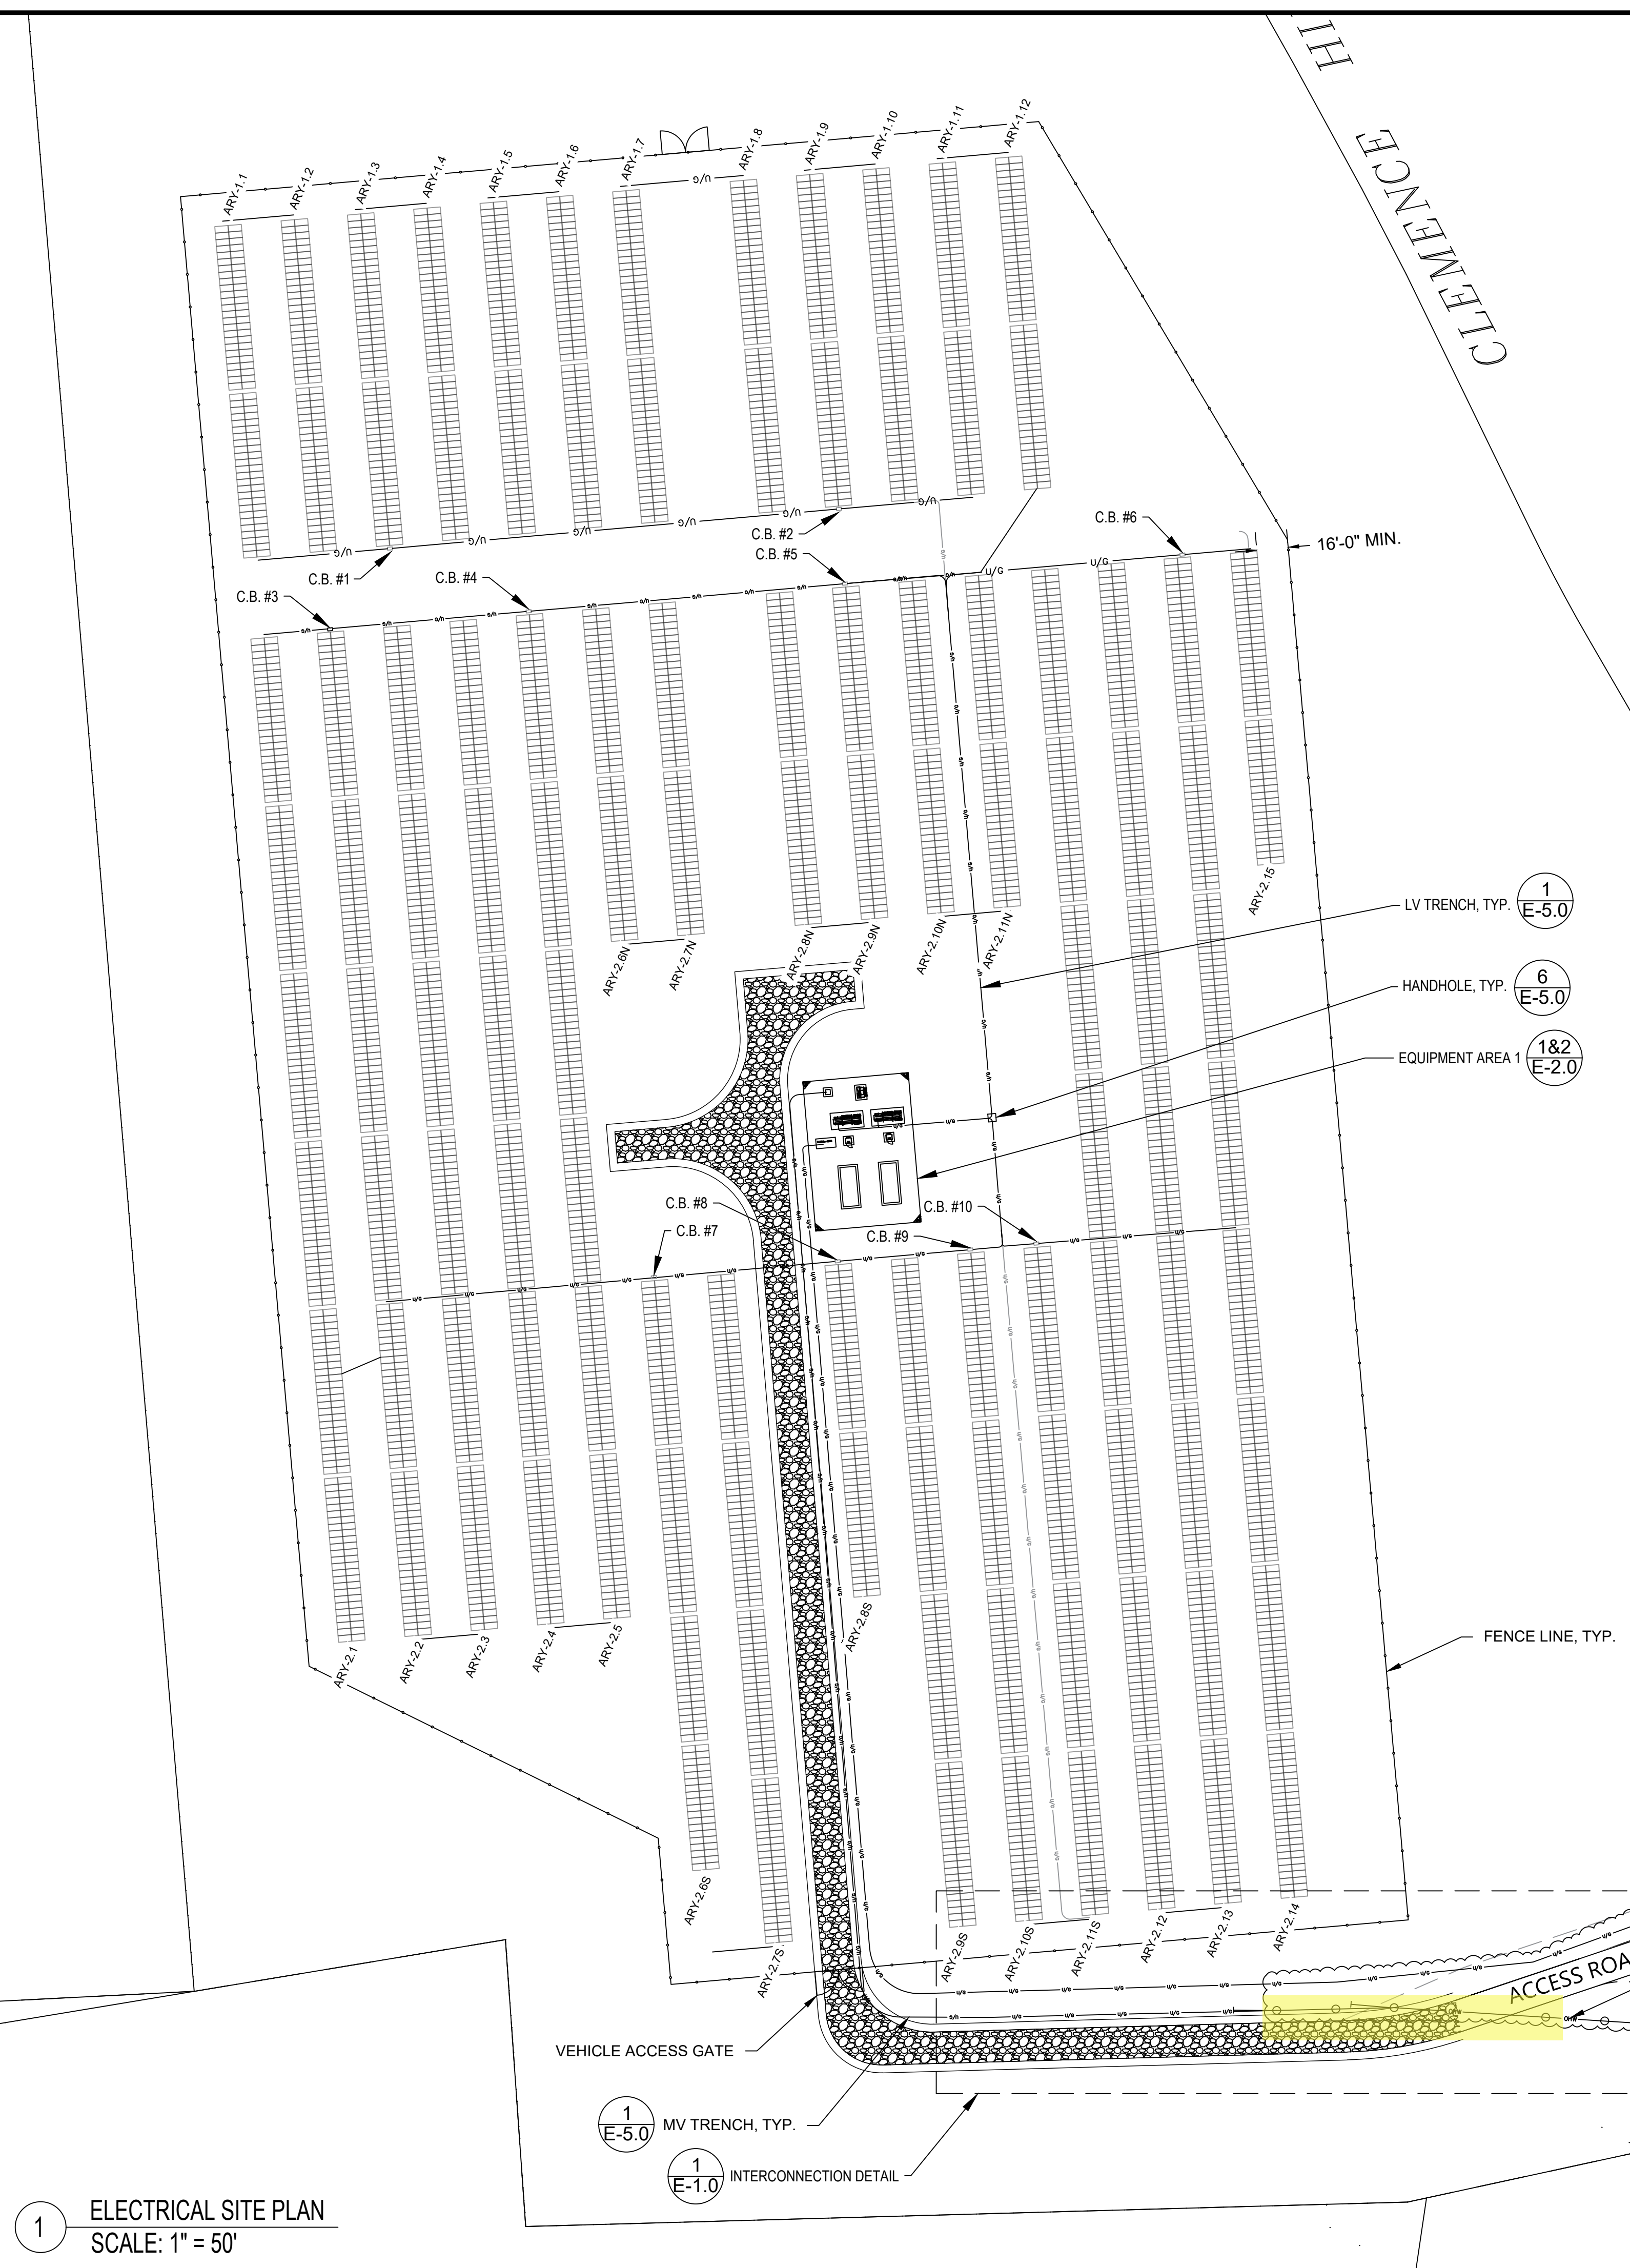

1 ELECTRICAL SITE PLAN
SCALE: 1" = 50'

1 MV TRENCH, TYP.
1 INTERCONNECTION DETAIL

1 LV TRENCH, TYP.
E-5.0

6 HANDHOLE, TYP.
E-5.0

1&2 EQUIPMENT AREA 1
E-2.0

8

8